


- WATER HEATER P2-20,22
- WELL PUMP P2-27,39
- WALL PACKS P1-17
- PANEL GFI P1-16
- FIRE ALARM P1-18

1 FIRST FLOOR PLAN
1/8" = 1'-0"

WAREHOUSE / PRODUCTION

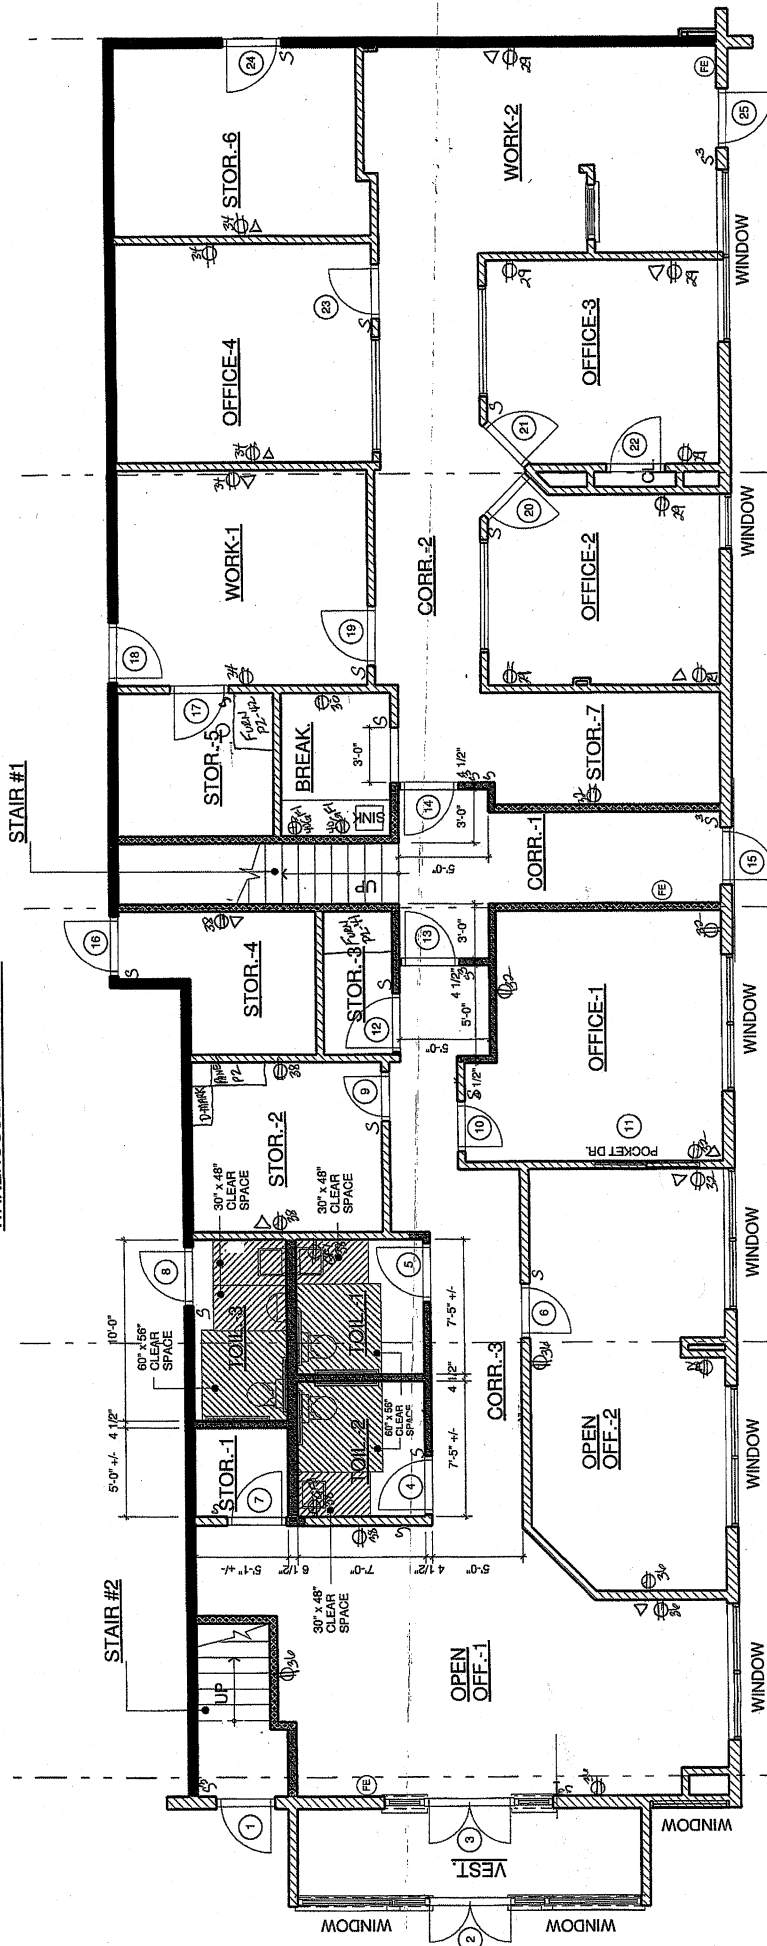

LEGEND:

- EXISTING WALLS


- PROPOSED NEW WALLS: 2"x4" WOOD STUDS @ 16" O.C. WITH 1/2" DRYWALL ON BOTH SIDES. INFILL EXISTING OPENINGS WITH

ALL CIRCUITS IN OFFICES ARE IN PANEL P2

LARGE SCALE FIRST FLOOR PLAN

SCALE: 1/4" = 1'-0"

1
A-4

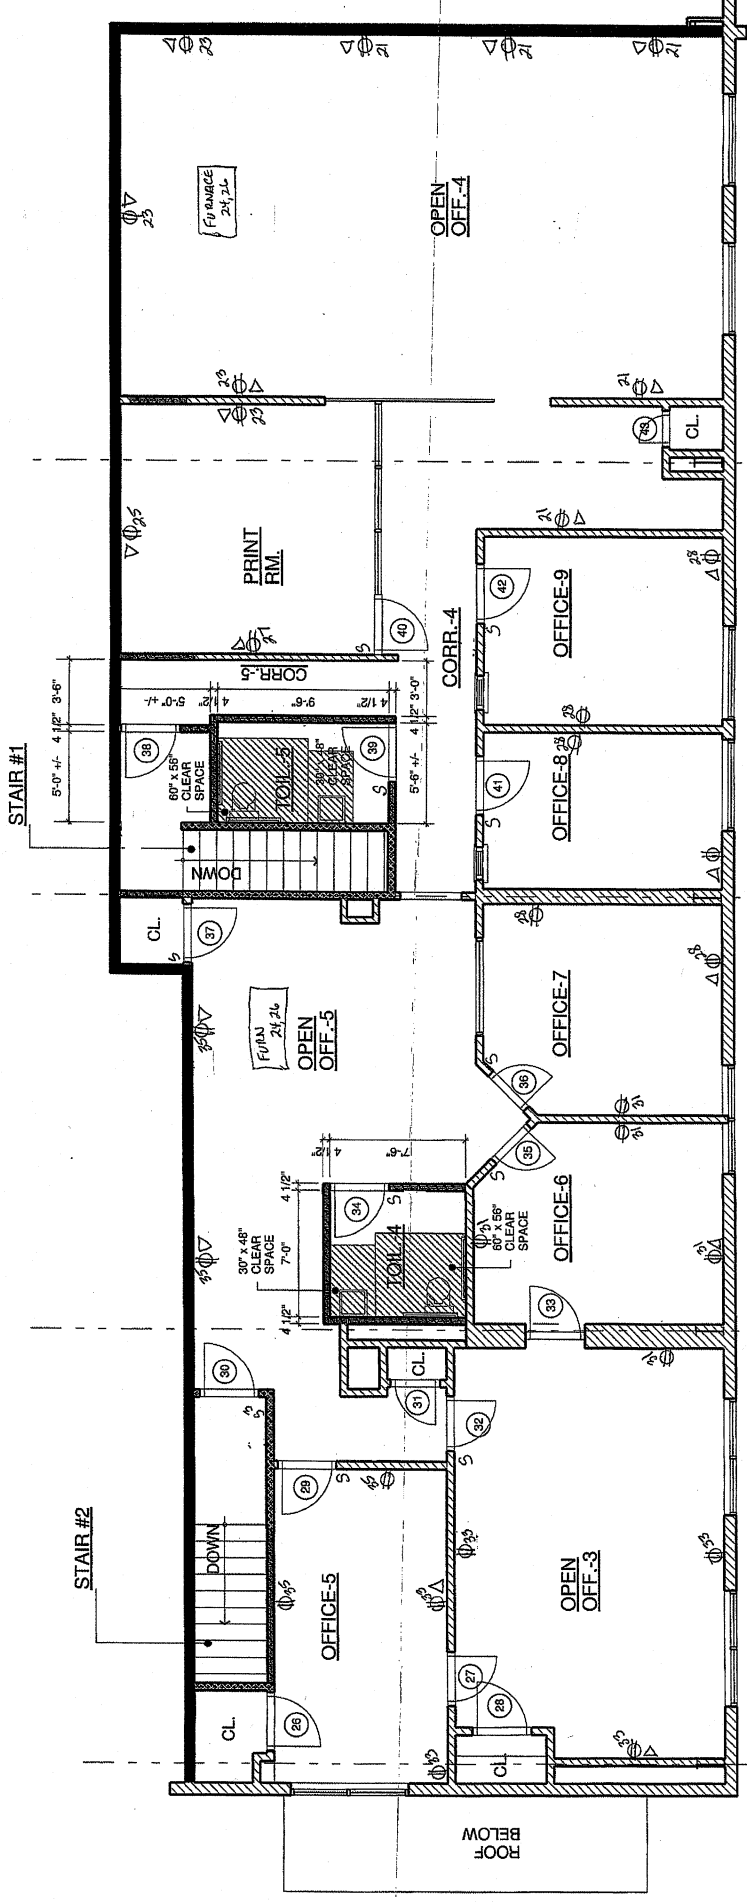

LEGEND:

▨ = EXISTING WALLS

■ = PROPOSED NEW WALLS, 2" x 4" WOOD STUDS @ 16" O.C. WITH 1/2" DRYWALL ON BOTH SIDES. INFILL EXISTING OPENINGS WITH STUDS AND DRYWALL TO MATCH EXG. INSTALL 5/8" TYPE - X DRYWALL AT INFILL OR NEW

ALL OFFICE ELECTRIC FED FROM PANEL P-2

LARGE SCALE SECOND FLOOR PLAN

SCALE: 1/4" = 1'-0"

1/4" = 1'-0"